



HPF 53B

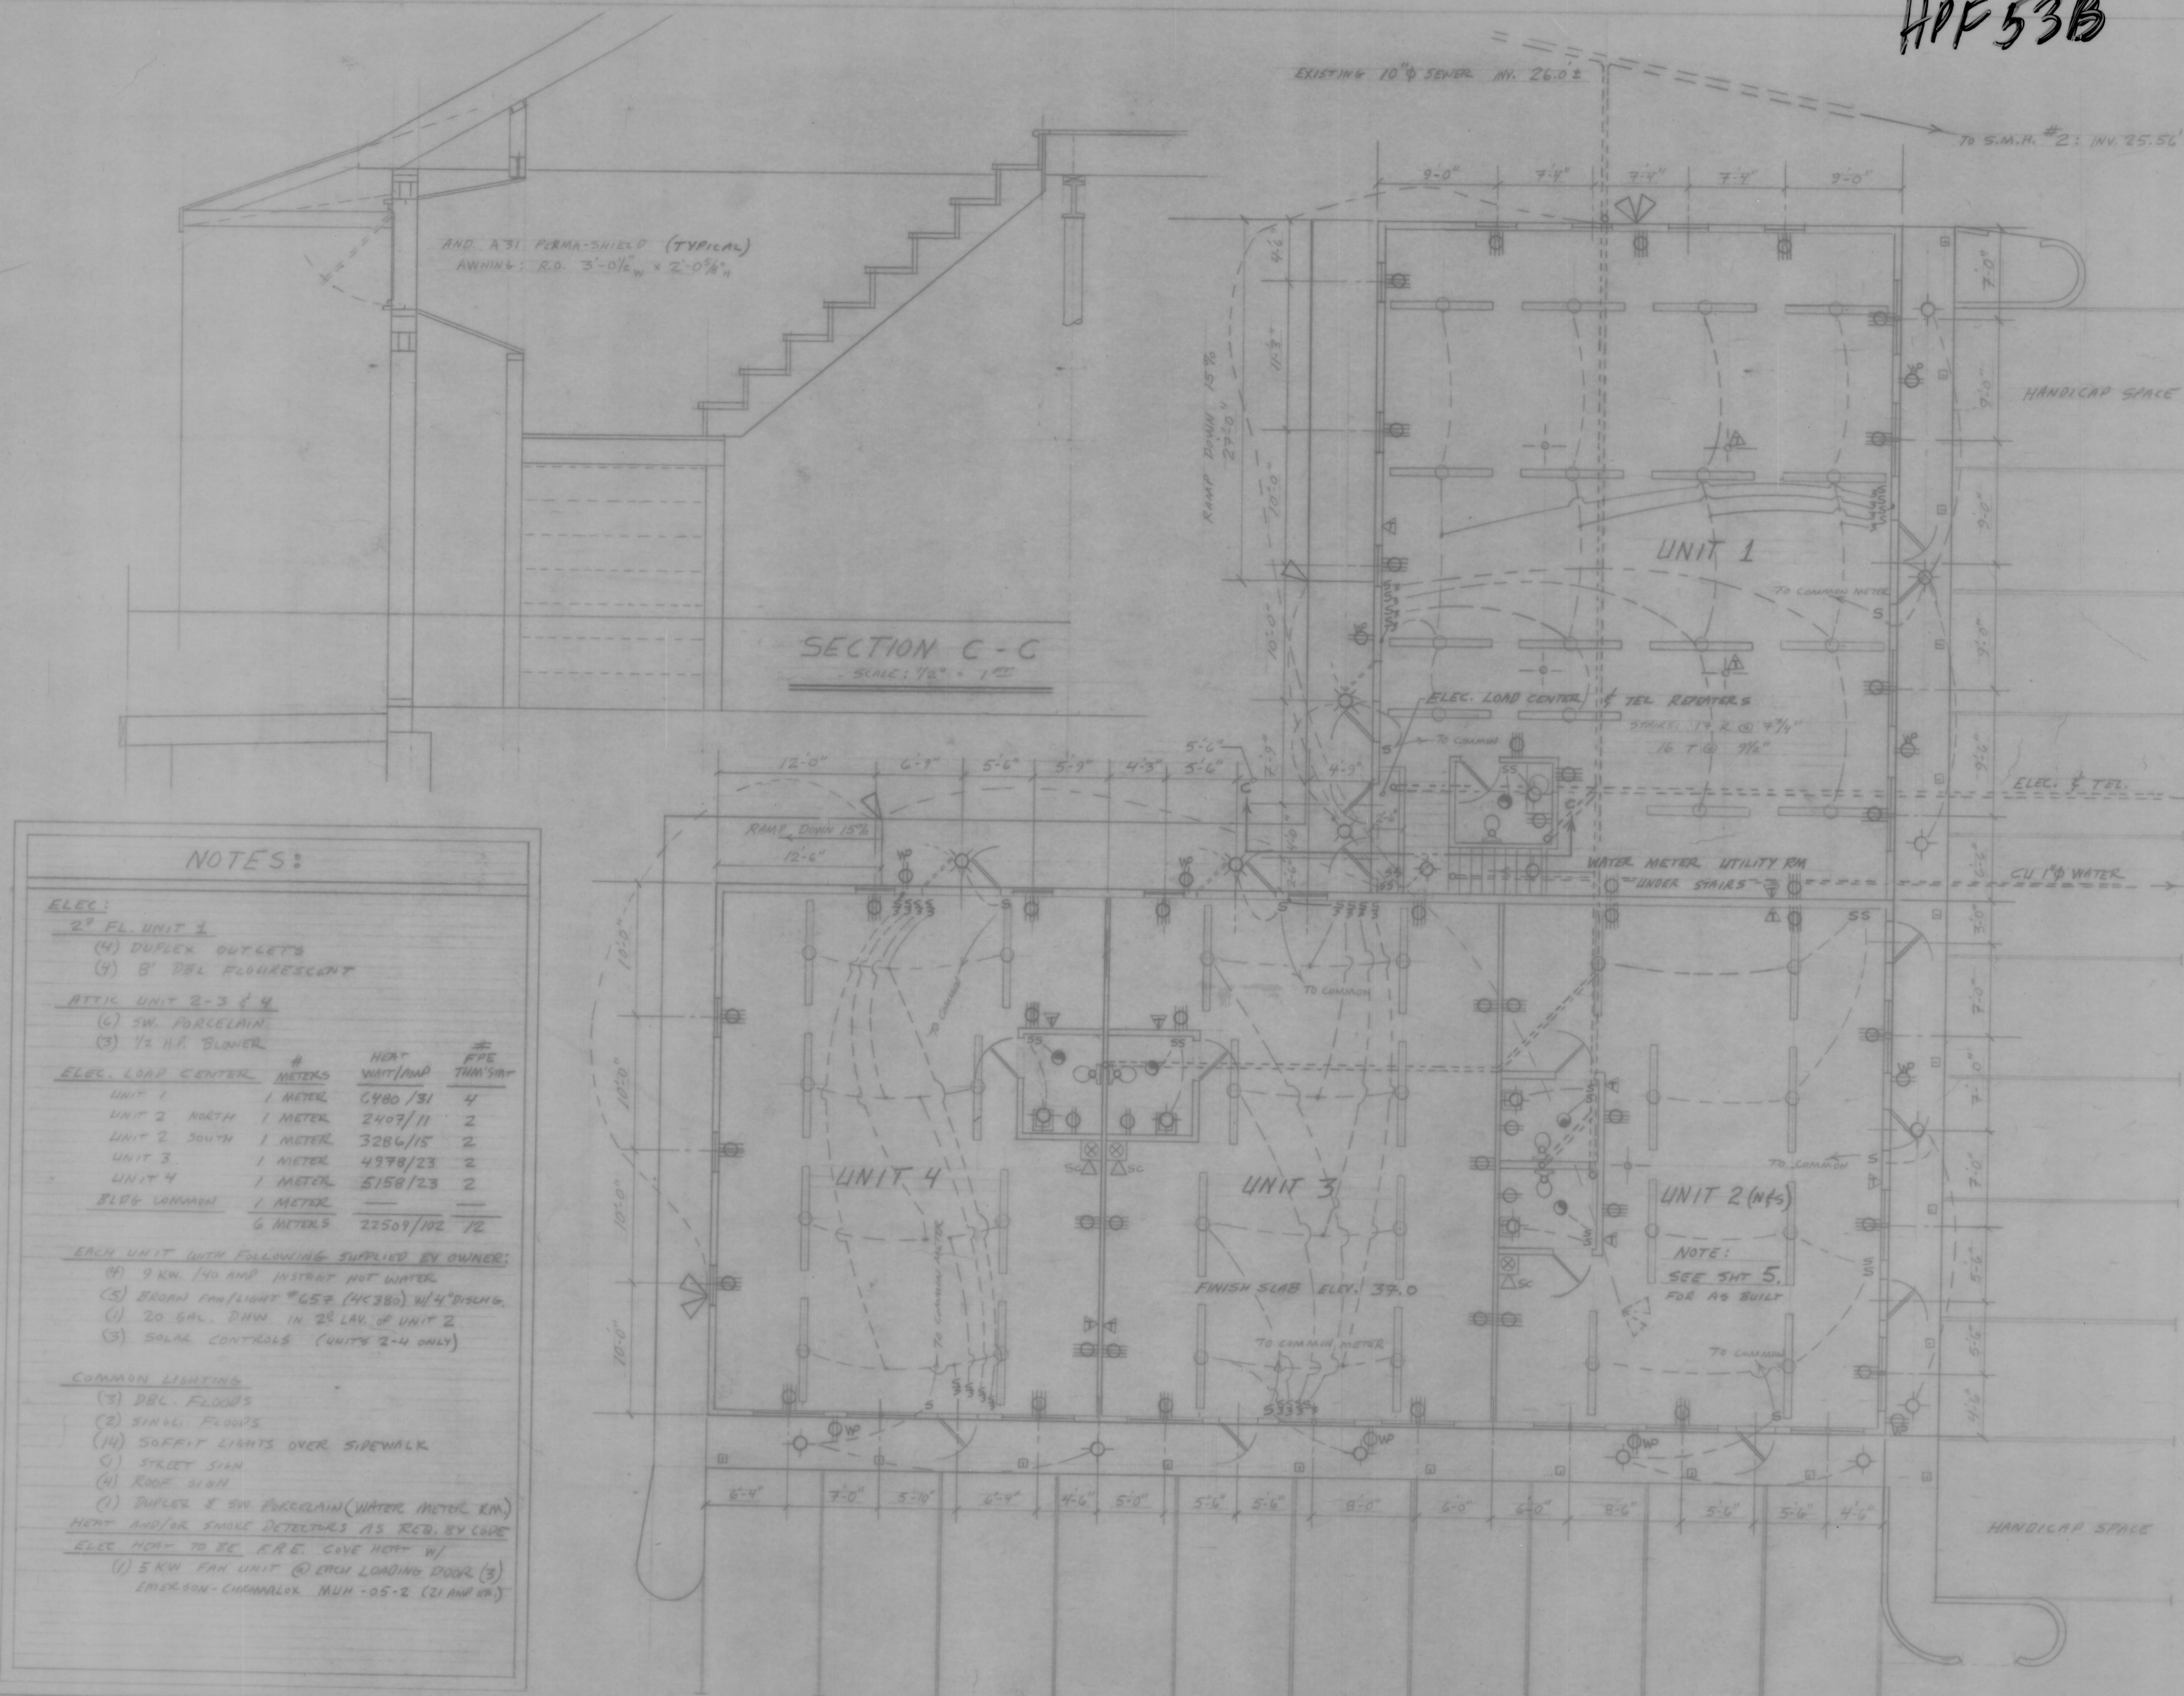

PETER L. RYAN
NO. 3372
REGISTERED PROFESSIONAL ENGINEER

M.F. SMITH ASSOCIATES GENERAL CONTRACTING JAMESTOWN, R.I. 423-2123	S-E: JAMESTOWN FOUR CORNERS INC. COMMERCIAL BUILDING PHASE 1: UNITS 1-4	MECHANICAL PLAN & STAIRWELL & PARKING	DATE: 2/10/84 REV: SCALE: 1/8" = 1'-0" (25' DIVISION)	4
--------------------------------------------------------------------------	-------------------------------------------------------------------------------	---------------------------------------------	----------------------------------------------------------------	---

HPF 53B

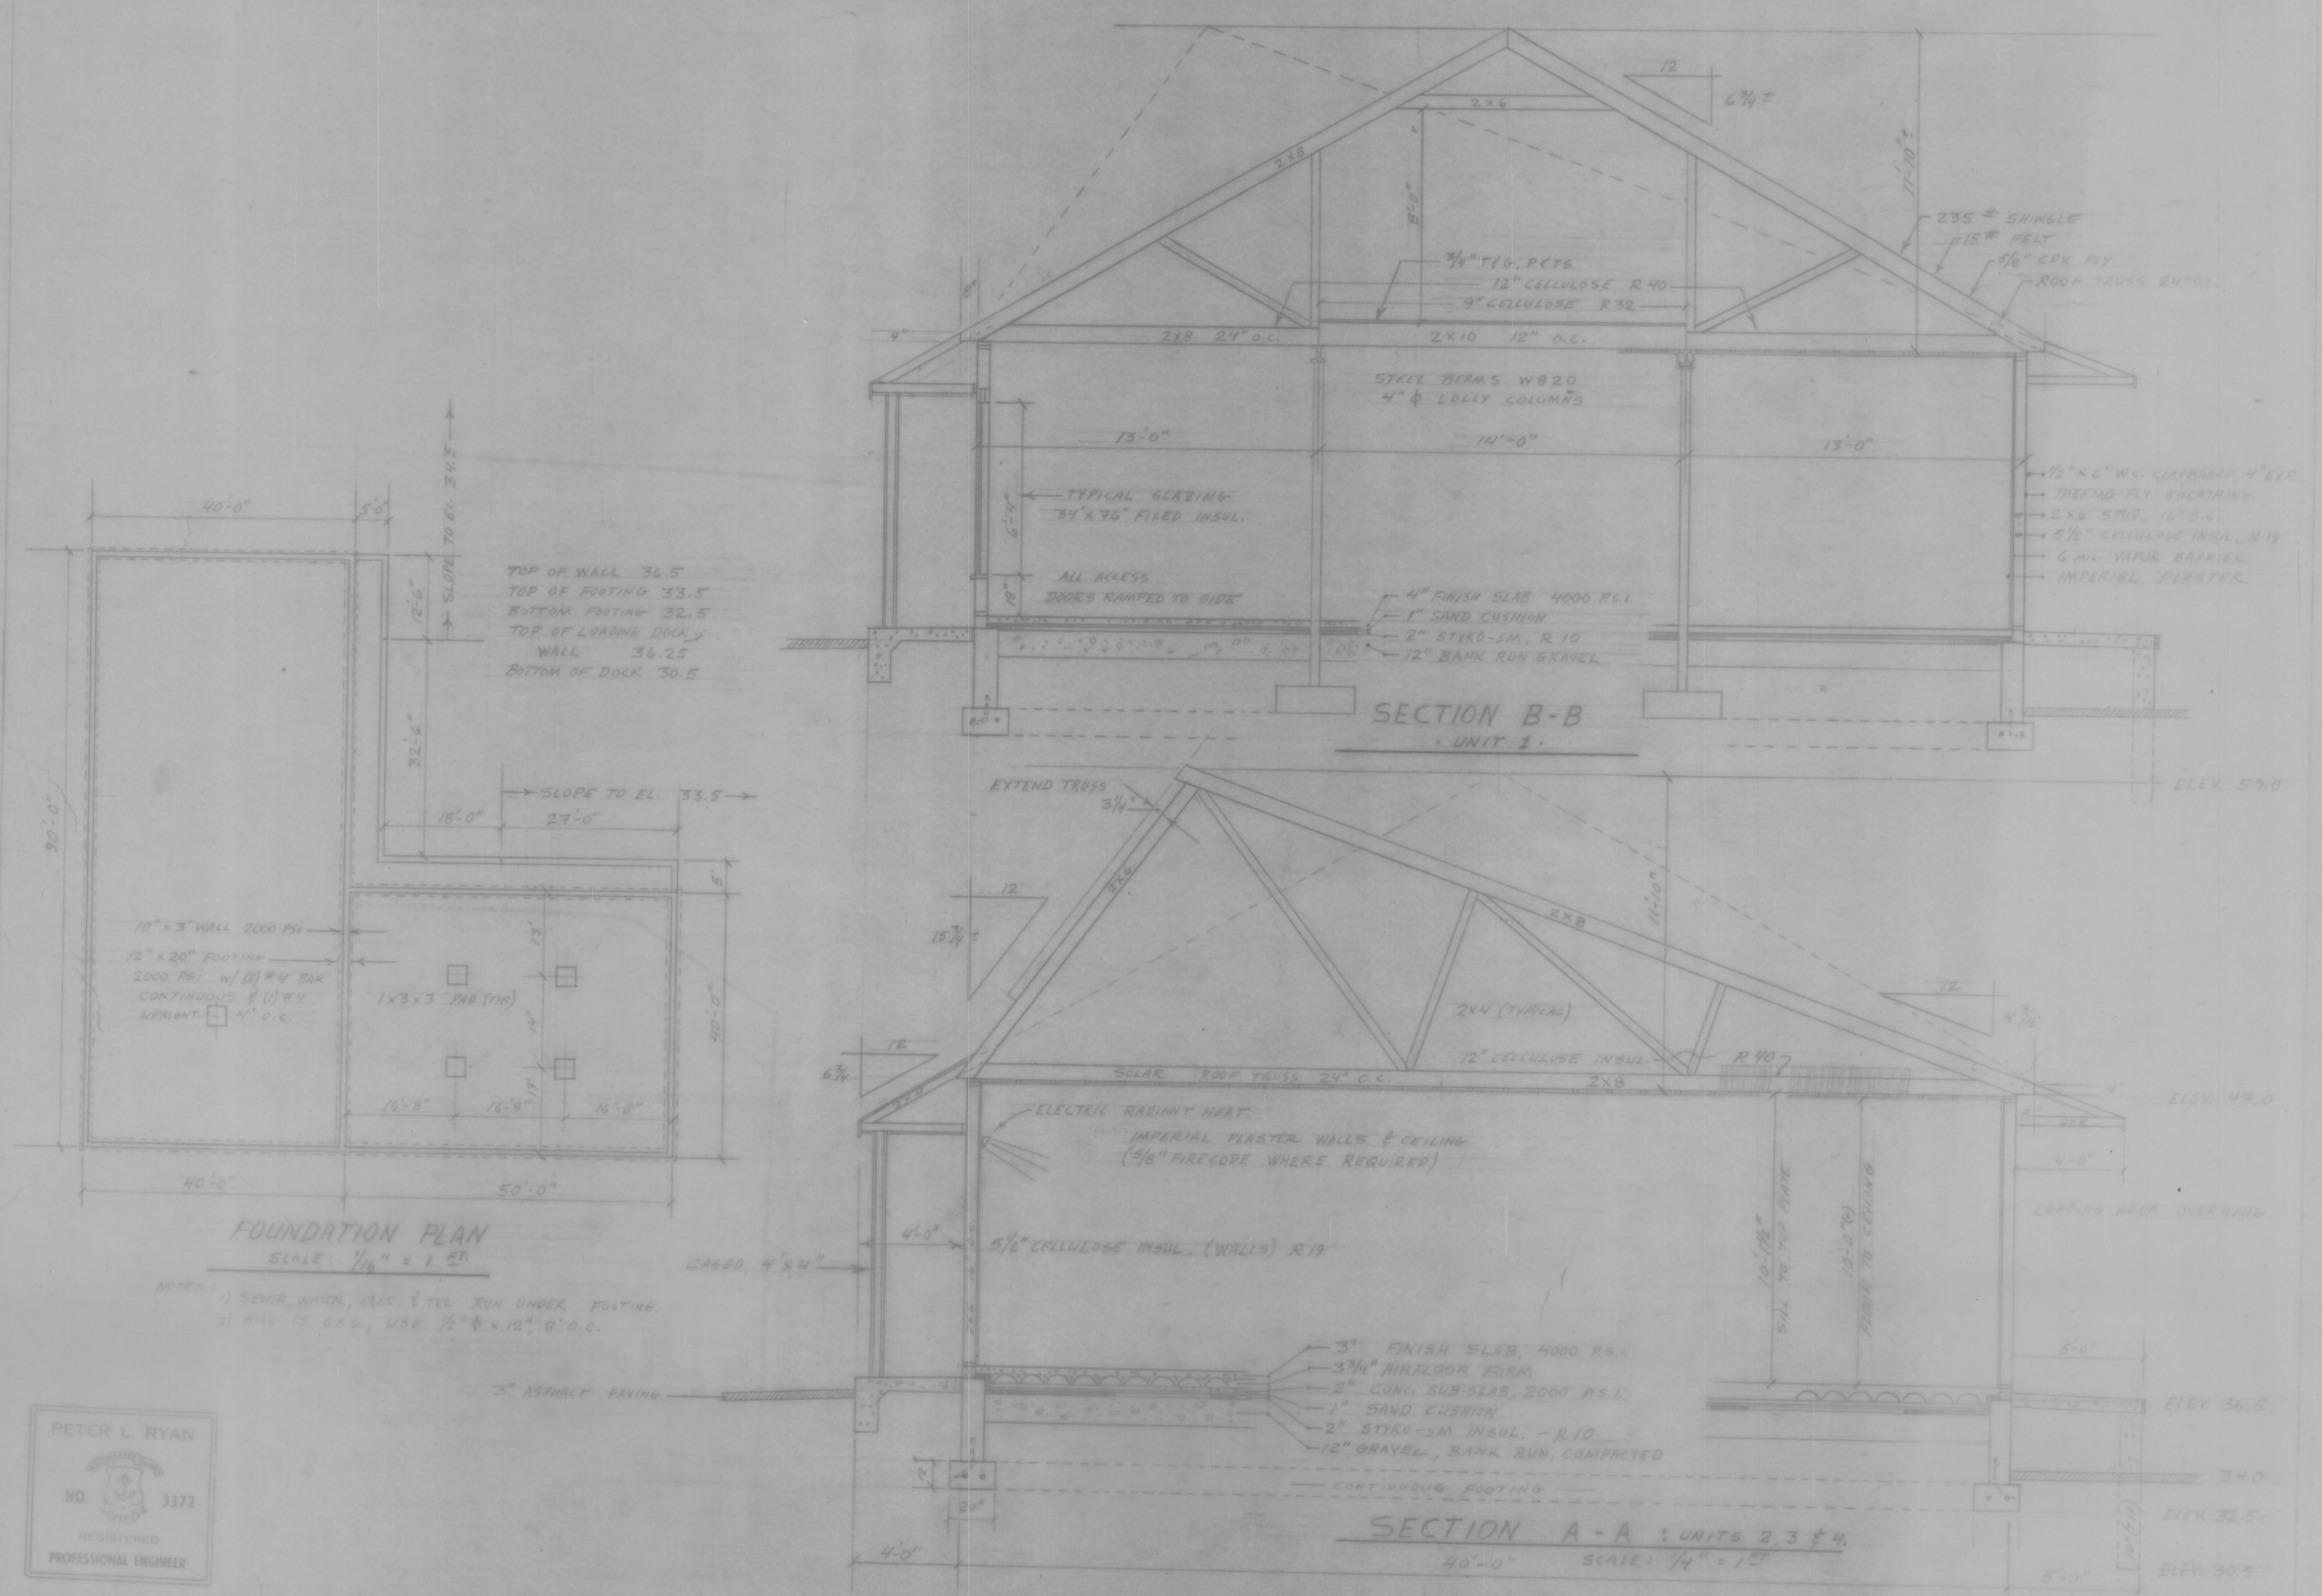

PETER L. RYAN
NO. 3372
REGISTERED PROFESSIONAL ENGINEER

M.F. SMITH ASSOCIATES GENERAL CONTRACTING JAMESTOWN, R.I. 423-2123	S-E: JAMESTOWN FOUR CORNERS, INC. COMMERCIAL BUILDING PHASE 1: UNITS 1-4	CONSTRUCTION SECTIONS & FOUNDATION PLAN	DATE: 1/2/84 REV: SCALE: 1/4" = 1'-0"	3
--------------------------------------------------------------------------	--------------------------------------------------------------------------------	-----------------------------------------------	---------------------------------------------	---